

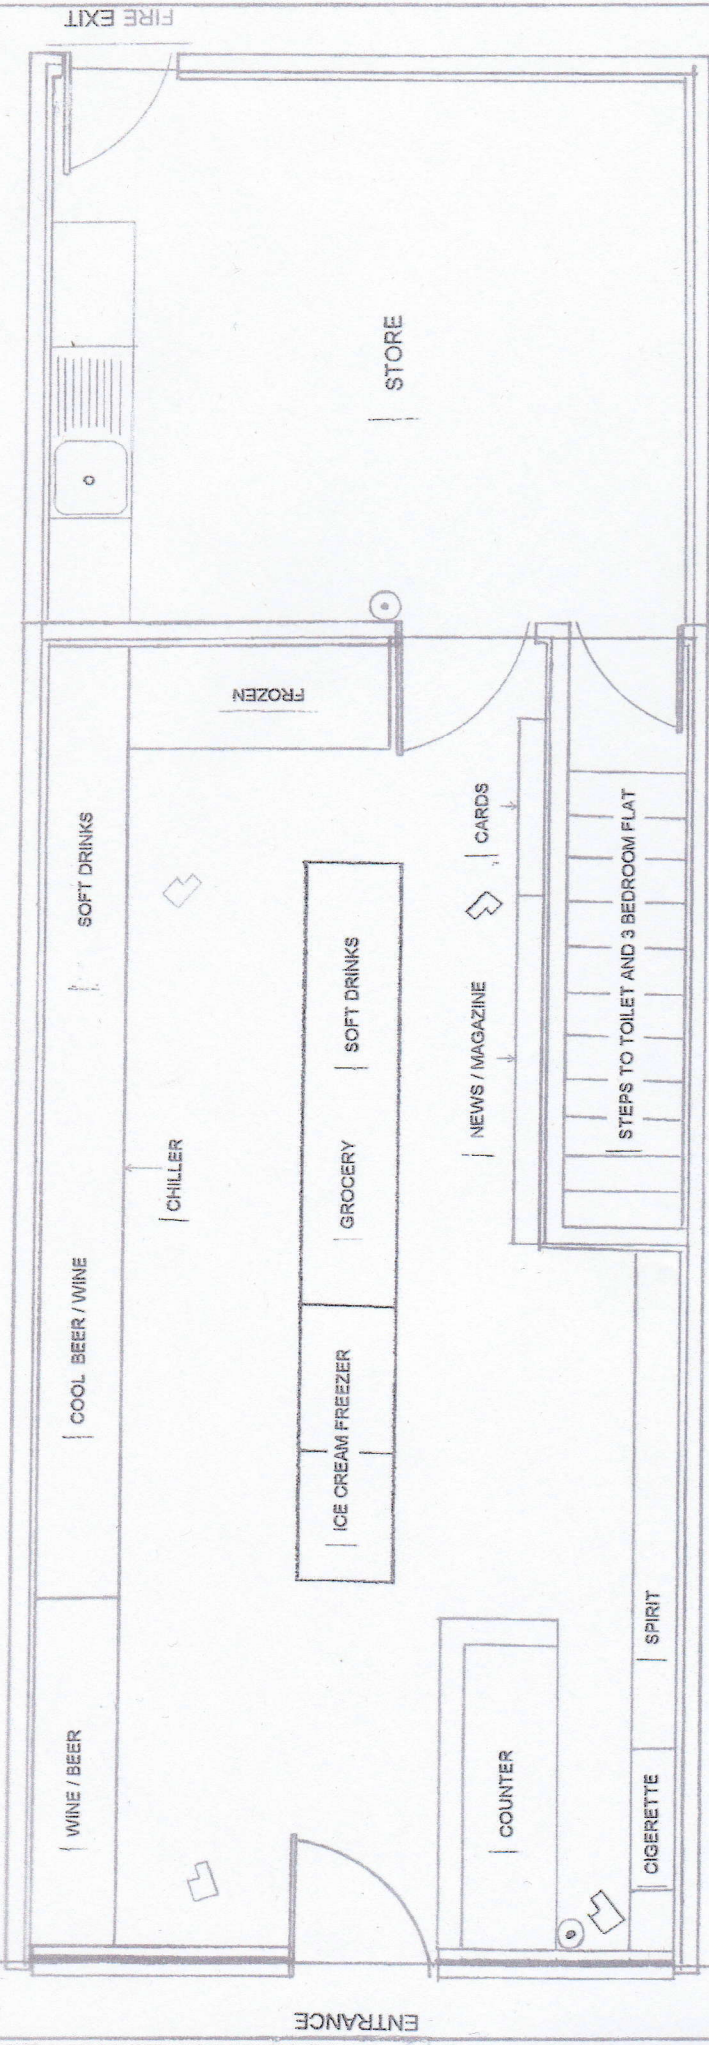


LEGEND

-  Fire Extinguisher
-  Camera



GROUND FLOOR PLAN

DAVIES NEWS AGENTS
 62 STATION ROAD
 MARCH
 PE15 8NP

DARAN ARTS
 Art by : SHIVA
 Dwg. No : DRN/PL/06/18
 Scale : 1 : 50
 Date : 10/08/2006