


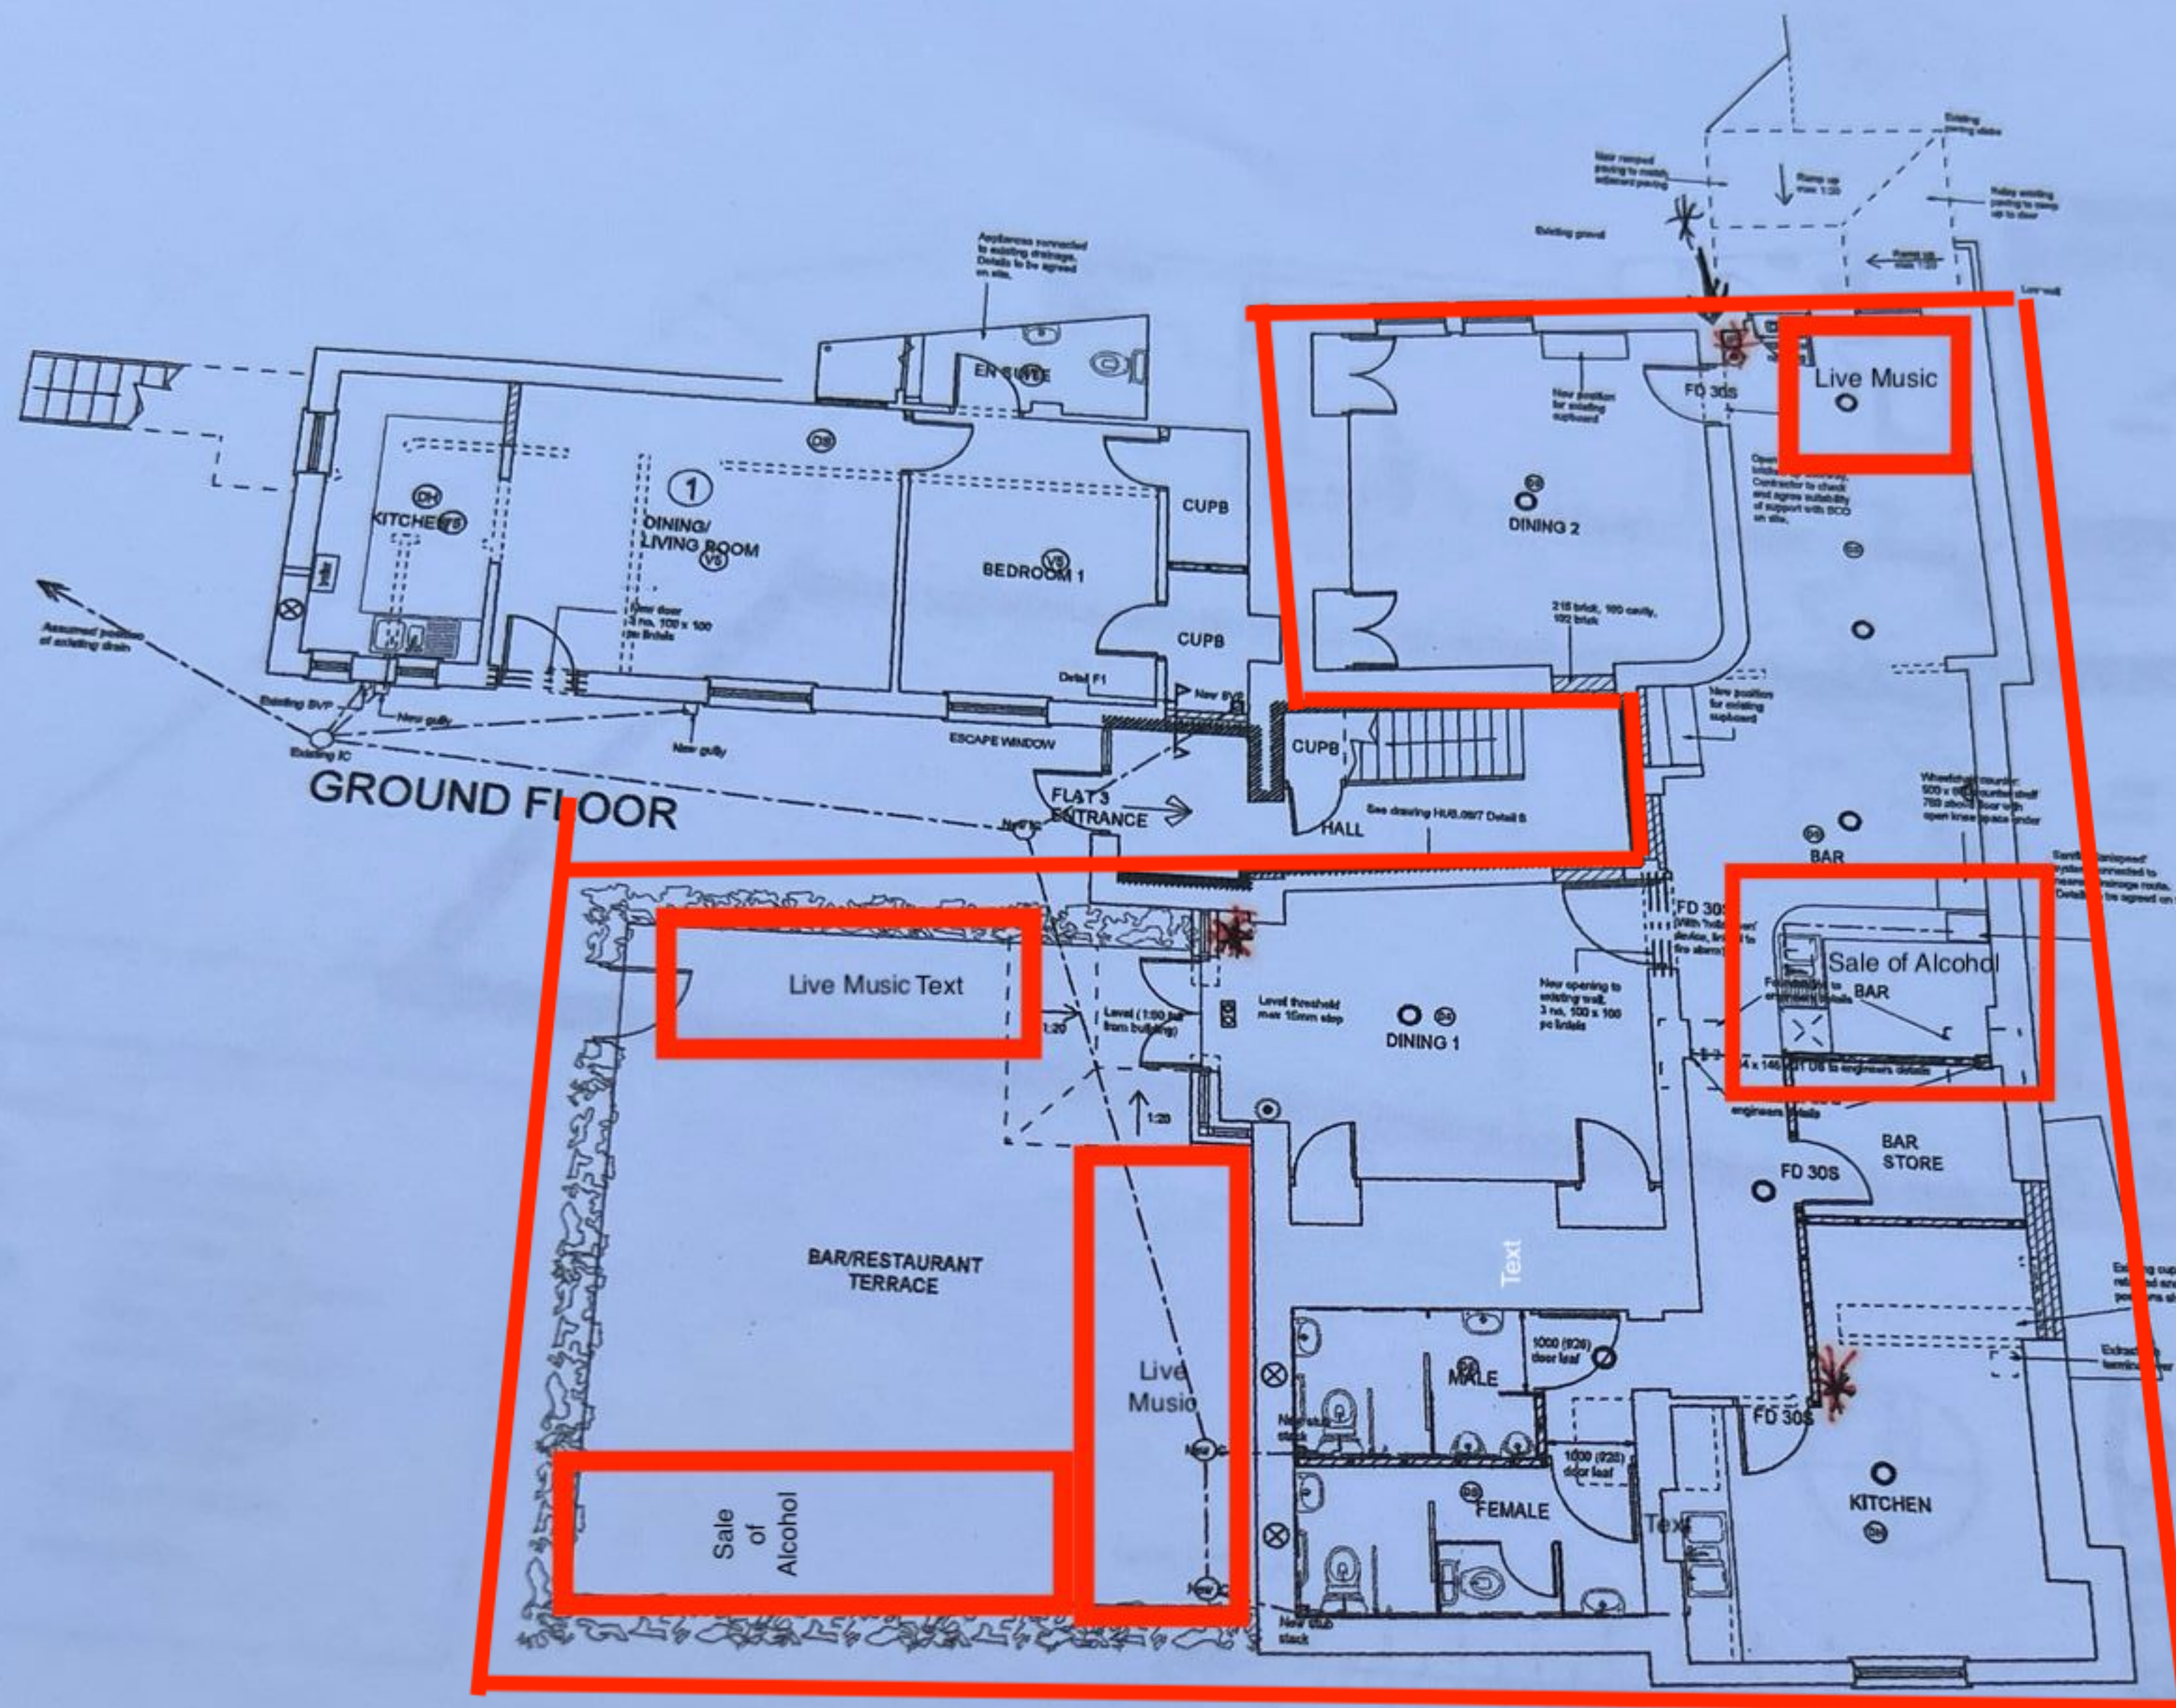

KEY:

- Energy efficient lighting
- Extract fans
- Smoke alarms
- Fixed fire extinguishers
- Alarm ground drainage
- Under ground drainage
- Brick walls
- Walls to be removed
- New walls


FIRE SAFETY & EMERGENCY KEY:

- Fire alarm indicator panel
- Fire alarm call point
- Audible warning devices
- Emergency lighting points
- 30 minute fire compartment walls
- FD 30S = 30 minute fire resisting door with self closing device and fire door keep shut sign (HQS)
- Illuminated Fire Exit boxes
- Automatic fire detection, heat / smoke
- FIRE EXTINGUISHERS**

THIS DRAWING TO BE
READ WITH ANDREW
FIREBRACE PARTNERSHIP
DRAWINGS



Scale 1:50 - A1

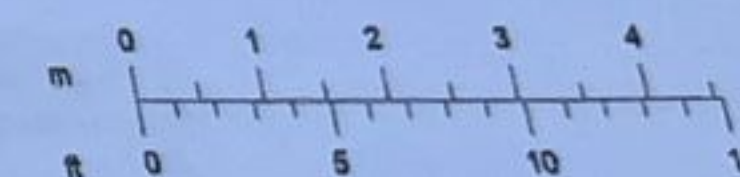

REVISIONS

ba
brand
associates
architects
24 Dartford Road
March PE15 8AB
tel (01354) 653 818
fax (01354) 651 951
mail@brand-associates.net

CONVERSION & ALTERATION
TO 12, MARKET PLACE
WHITTLESEY
PETERBOROUGH

MR & MRS HUBBARD

PROPOSED GROUND
FLOOR PLAN

1:50 : HJC : MAR 2010

HUB.09 : 3.1 : C